




FRONT ELEVATION
SCALE: 3/16"=1'-0"

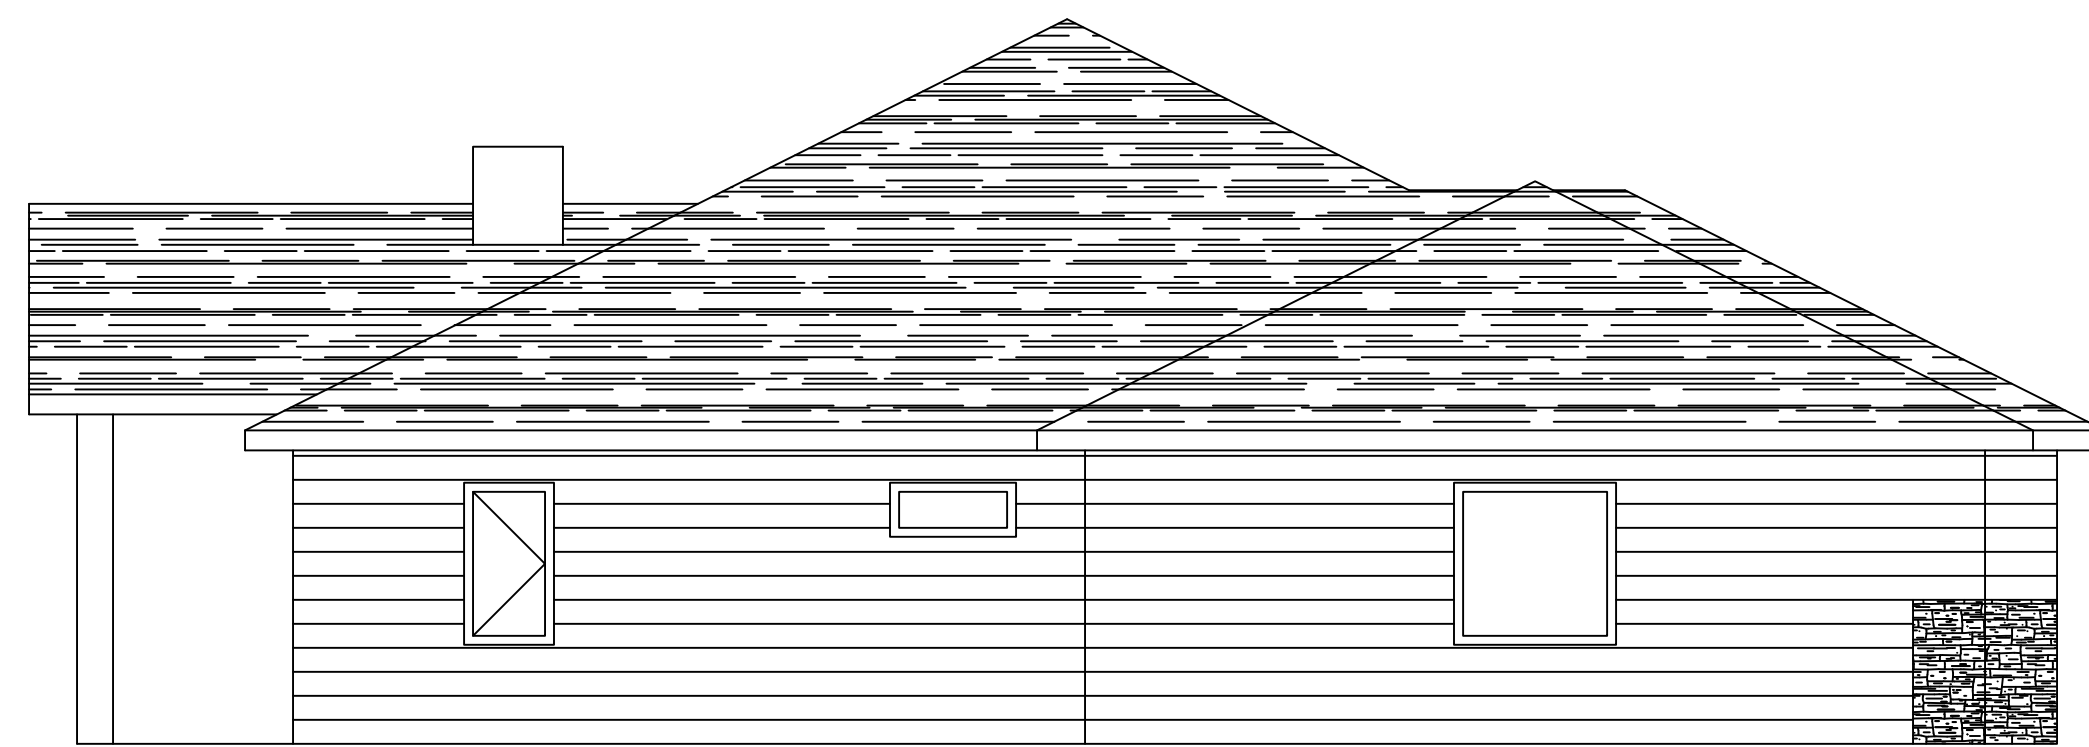

LEFT ELEVATION
SCALE: 3/16"=1'-0"

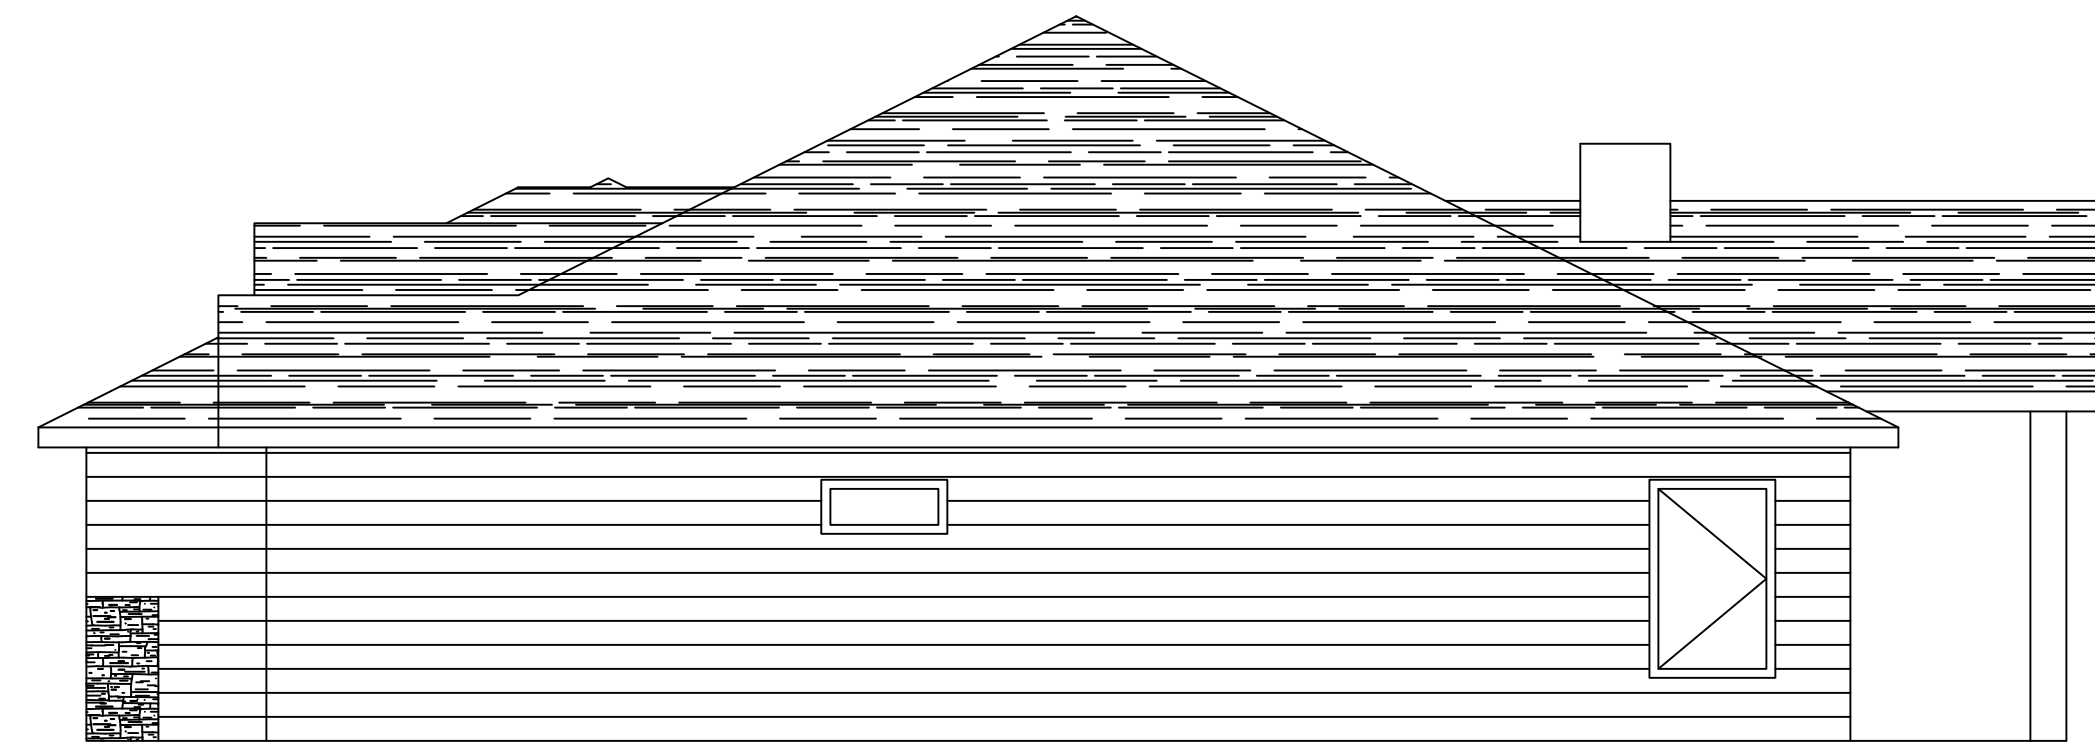


RIGHT ELEVATION
SCALE: 3/16"=1'-0"

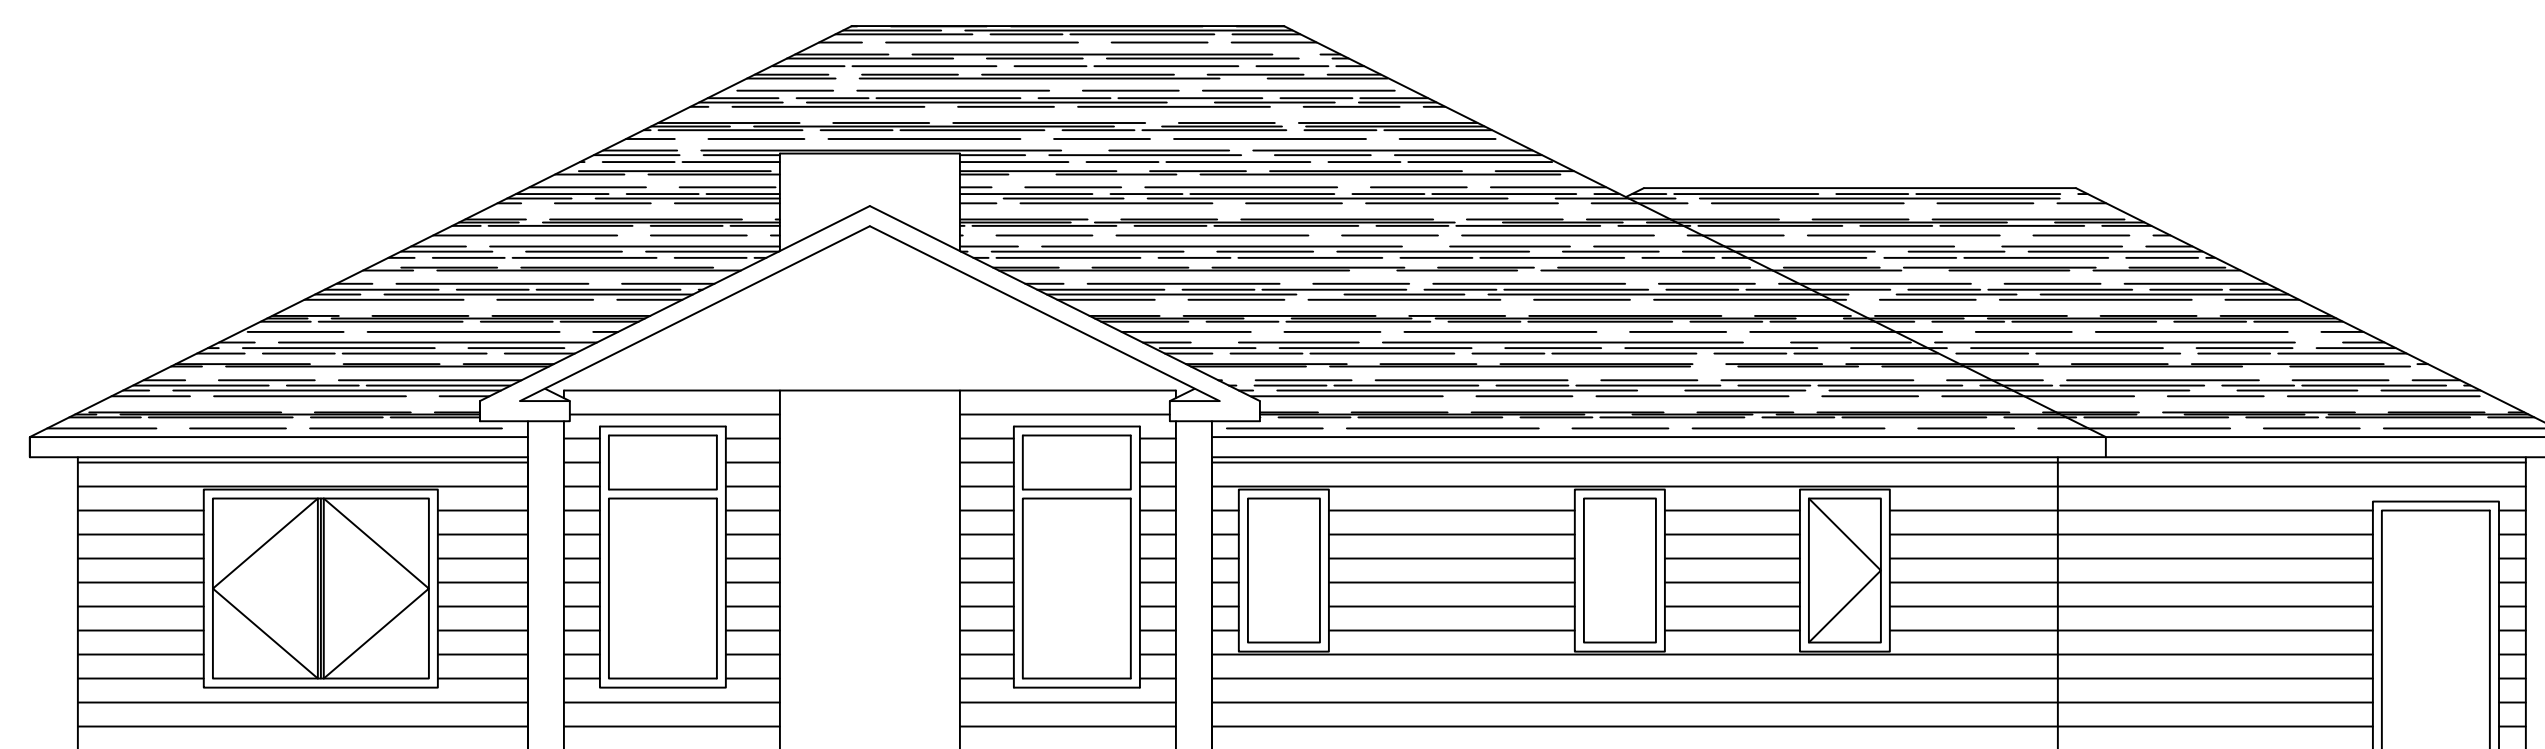

BACK ELEVATION
SCALE: 3/16"=1'-0"

DEVOTED BUILDERS		
LOT 11 ELEVATIONS		
DRAWN BY: MARK JOHNSON DESIGNS INC.		
SCALE: SHOWN	DATE: 4/16/19	SHT. 1

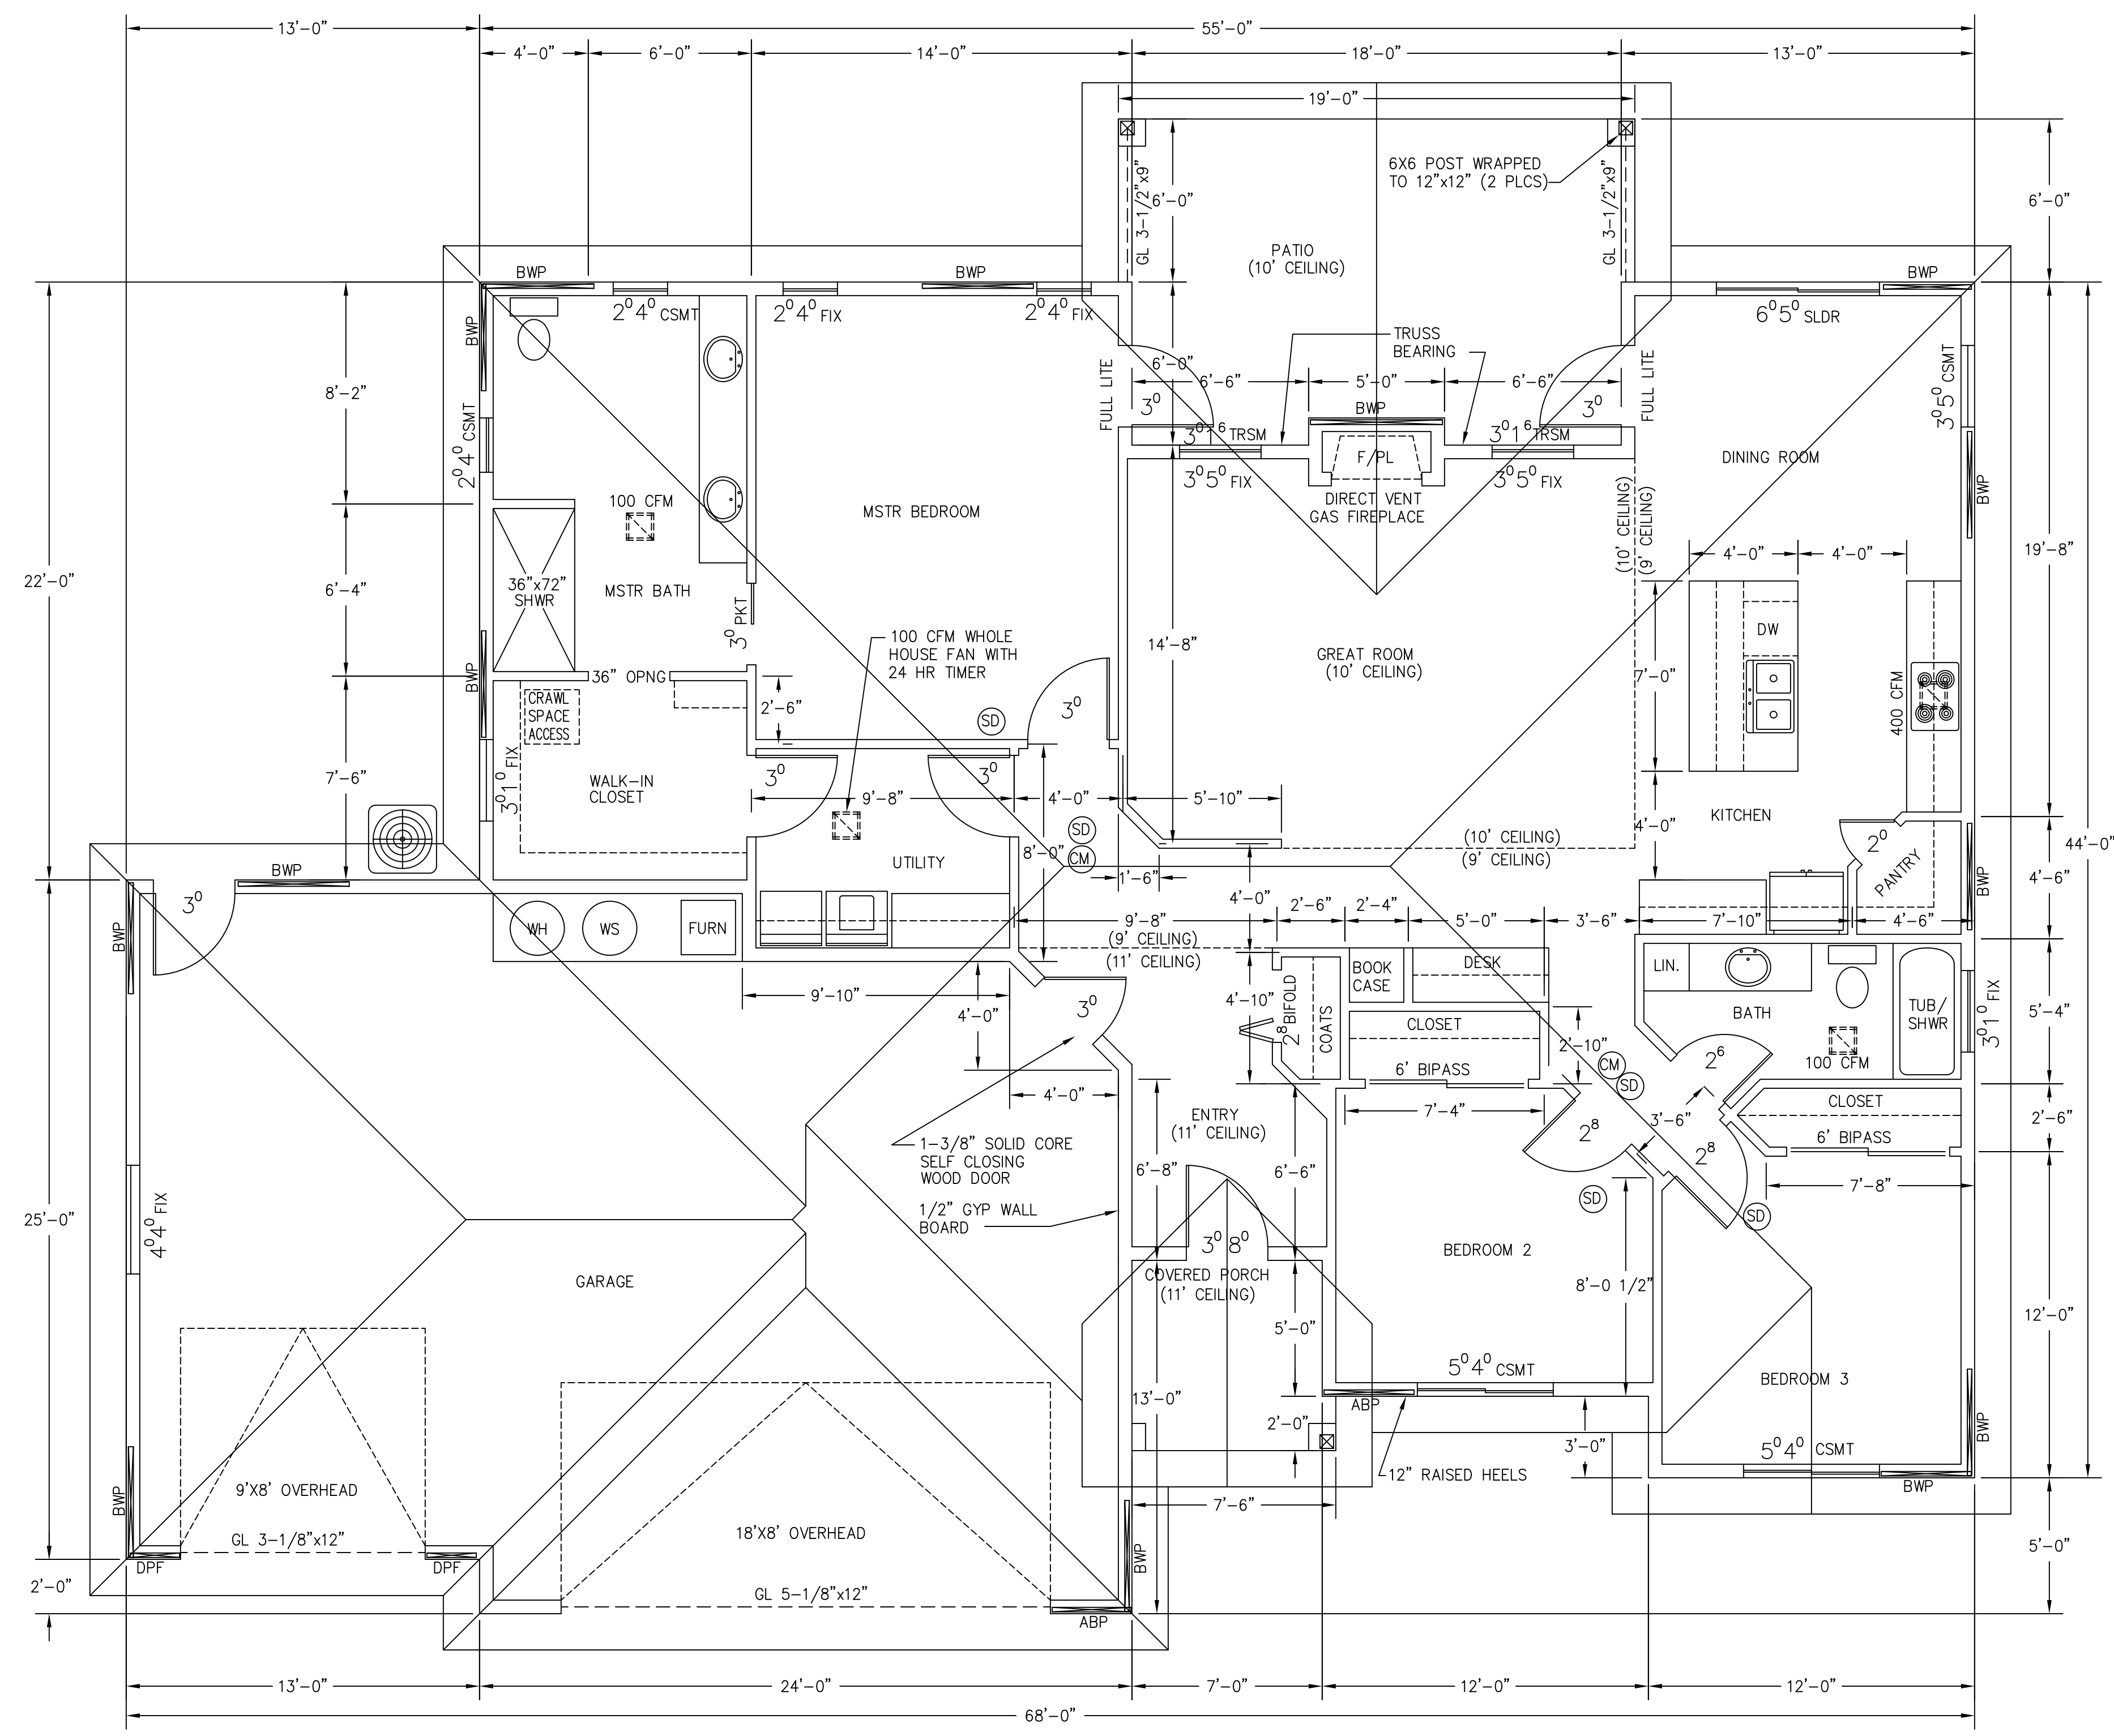

BRACED WALL PANEL SCHEDULE	
BWP	MINIMUM 4' PANEL: 7/16" OSB SHEATHING, BLOCK AND NAIL ALL EDGES 6" O.C. W/ 8d COMMON, 1-3/8" MINIMUM PENETRATION. NAIL FIELD 12" O.C. FOR 16" STUD SPACING OR 6" O.C. FOR 24" STUD SPACING.
ABP	MINIMUM 2'-8" PANEL: 7/16" OSB SHEATHING, BLOCK AND NAIL ALL EDGES 4" O.C. W/ 8d COMMON, 1-3/8" MINIMUM PENETRATION. NAIL FIELD 12" O.C. SIMPSON STHD14 OR HTT22 (OR EQUIVALENT) EACH END OF PANEL, W/ (2) 1/2"x10 ANCHOR BOLTS.
IBWP	MINIMUM 4'-0" PANEL: 1/2" GWB BOTH SIDES, 5d NAIL (OR SCREWS) AT 7" O.C. SOLE PLATE NAILED INTO SOLID BLOCKING (PERPENDICULAR TO SOLE PLATE) BETWEEN JOISTS, OR LINE UP JOIST UNDER SOLE PLATE

LEGEND	
ABP	32" ALT. BRACED PANEL (ABW)
BWP	48" BRACED WALL PANEL (WSP)
DPF	DOUBLE PORTAL FRAME (CS-PF)
SPF	SINGLE PORTAL FRAME (CS-PF)
IBWP	INTERIOR BRACED WALL PANEL (GB)
(T)	TEMPERED SAFETY GLASS
(SD)	SMOKE DETECTOR
(CM)	CARBON MONOXIDE SENSOR
(E)	EXHAUST FAN

SQUARE FOOTAGE	
TOTAL LIVING	1,762 SQ. FT.
GARAGE	911 SQ. FT.

FLOOR PLAN
 SCALE: 1/4"=1'-0"
 (9' CEILING, UNLESS NOTED OTHERWISE)

DEVOTED BUILDERS		
LOT 11 FLOOR PLAN		
DRAWN BY: MARK JOHNSON DESIGNS INC.		
SCALE: 1/4"=1'-0"	DATE: 4/16/19	SHT. 2